

48 HOURS BEFORE DIGGING
CALL 1-800-272-3020
TO LOCATE UTILITY LINES


Scale 1" = 20'

0 30' 60'

These drawings, specifications and other documents are instruments of service for use solely on this Project. Meyer, Meyer, LaCroix & Hixson, Inc. shall be deemed the author and owner of all such Instruments and shall retain all common law, statutory and copyrights. The Instruments shall not be used, copied or reproduced for any purpose, without the prior written agreement of Meyer, Meyer, LaCroix & Hixson, Inc. Any unauthorized use shall be at the Owner's sole risk.

[illegible]

Ⓐ	2-15-12	CONTRACT 1, CHANGE ORDER NO. 2	G.T.
Ⓐ	2-2-11	CHANGE ORDER NO. 1	G.T.
Ⓐ	11-9-10	CONTRACT 4 SUBMITTAL REVIEW	G.T.
Ⓐ	8-18-10	ADDENDUM NO. 1	G.T.

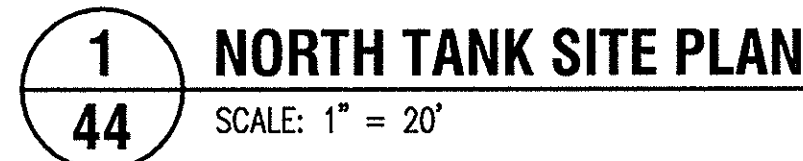

1. UNLESS OTHERWISE SHOWN ON SITE PLAN, ALL UNDERGROUND SITE PIPING SHALL BE DR 18, PVC CLASS 235, C-900 PIPE.
2. ALL WORK AT THIS SITE SHALL BE PAID FOR UNDER THE GENERAL SITE WORK PAY ITEM FOR CONTRACT 1 UNLESS SEPARATE UNIT PRICES ARE INCLUDED IN THE BID PROPOSAL.
3. ALL WATER MAINS SHALL HAVE A MINIMUM OF 30" COVER.
4. ALL LOCKS INSTALLED IN THIS CONTACT SHALL BE KEYED TO ONE SYSTEM.
5. ALL AREAS DISTURBED BY CONSTRUCTION SHALL BE SEEDED AND FERTILIZED IN ACCORDANCE WITH THE SPECIFICATIONS.
6. ALL ABOVE GROUND EXPOSED PIPING SHALL INSULATED IN ACCORDANCE WITH THE SPECIFICATIONS.
7. CONTRACT 1 SHALL REMOVE EXISTING BRUSH PILES AND STUMPS PRIOR TO MOBILIZATION BY CONTRACTS 3 AND 4
8. THE ENTIRE SITE MUST BE GRADED TO DRAIN, SEEDED, AND FERTILIZED. GRADING ON ALL SITES SHALL BE THE COMPLETED PRIOR TO FENCING.
9. THE EXISTING BARBED WIRE FENCE ALONG TANK SITE SHALL BE REMOVED AND DISPOSED OF. THE CONTRACTOR SHALL FURNISH AND INSTALL CORNER POSTS AS REQUIRED TO MAINTAIN EXISTING BARBED WIRE FENCE BEYOND THE TANK SITE PROPERTY.
10. THE MUD PIT FOR THE WELL SHALL BE LOCATED SO AS NOT TO INTERFERE WITH OTHER STRUCTURES OR DEVELOPMENT OF THE SITE.

מנהל & ח

Meyer, Meyer, LaCroix & Hixson, Inc.
Consulting Engineers & Land Surveyors
 3666 Government Street, Alexandria, LA 71302
 Phone: (318) 448-0888 - Fax: (318) 448-0885


ALEXANDRIA BATON POLICE BUSTON

ALEXANDRIA-BATON ROUGE-KOUSTON

NORTHWEST ALLEN PARISH WATERWORKS DISTRICT

WATER SYSTEM IMPROVEMENTS

THE UNIVERSITY OF CHICAGO

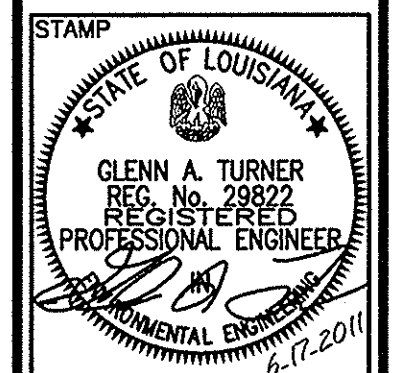

PROJECT NO. 4067
DATE: JULY 2010
DESIGNED BY: GT
CHECKED BY: TD
DRAWN BY: JLV
CHECKED BY: GT
DRAWING NO.

44

SHEET 44 OF 62

RECORD DRAWINGS